


목록

수성아트피아_무대기계장치 단면배치도.....	1
수성아트피아_무대기계장치 구동부 배치평면도.....	2
수성아트피아_무대기계장치 배치도.....	3
수성아트피아_무대기계장치 배치도1.....	4
수성아트피아_무대기계장치 상부 평면배치도.....	5
수성아트피아_무대기계장치 하부 평면배치도.....	6

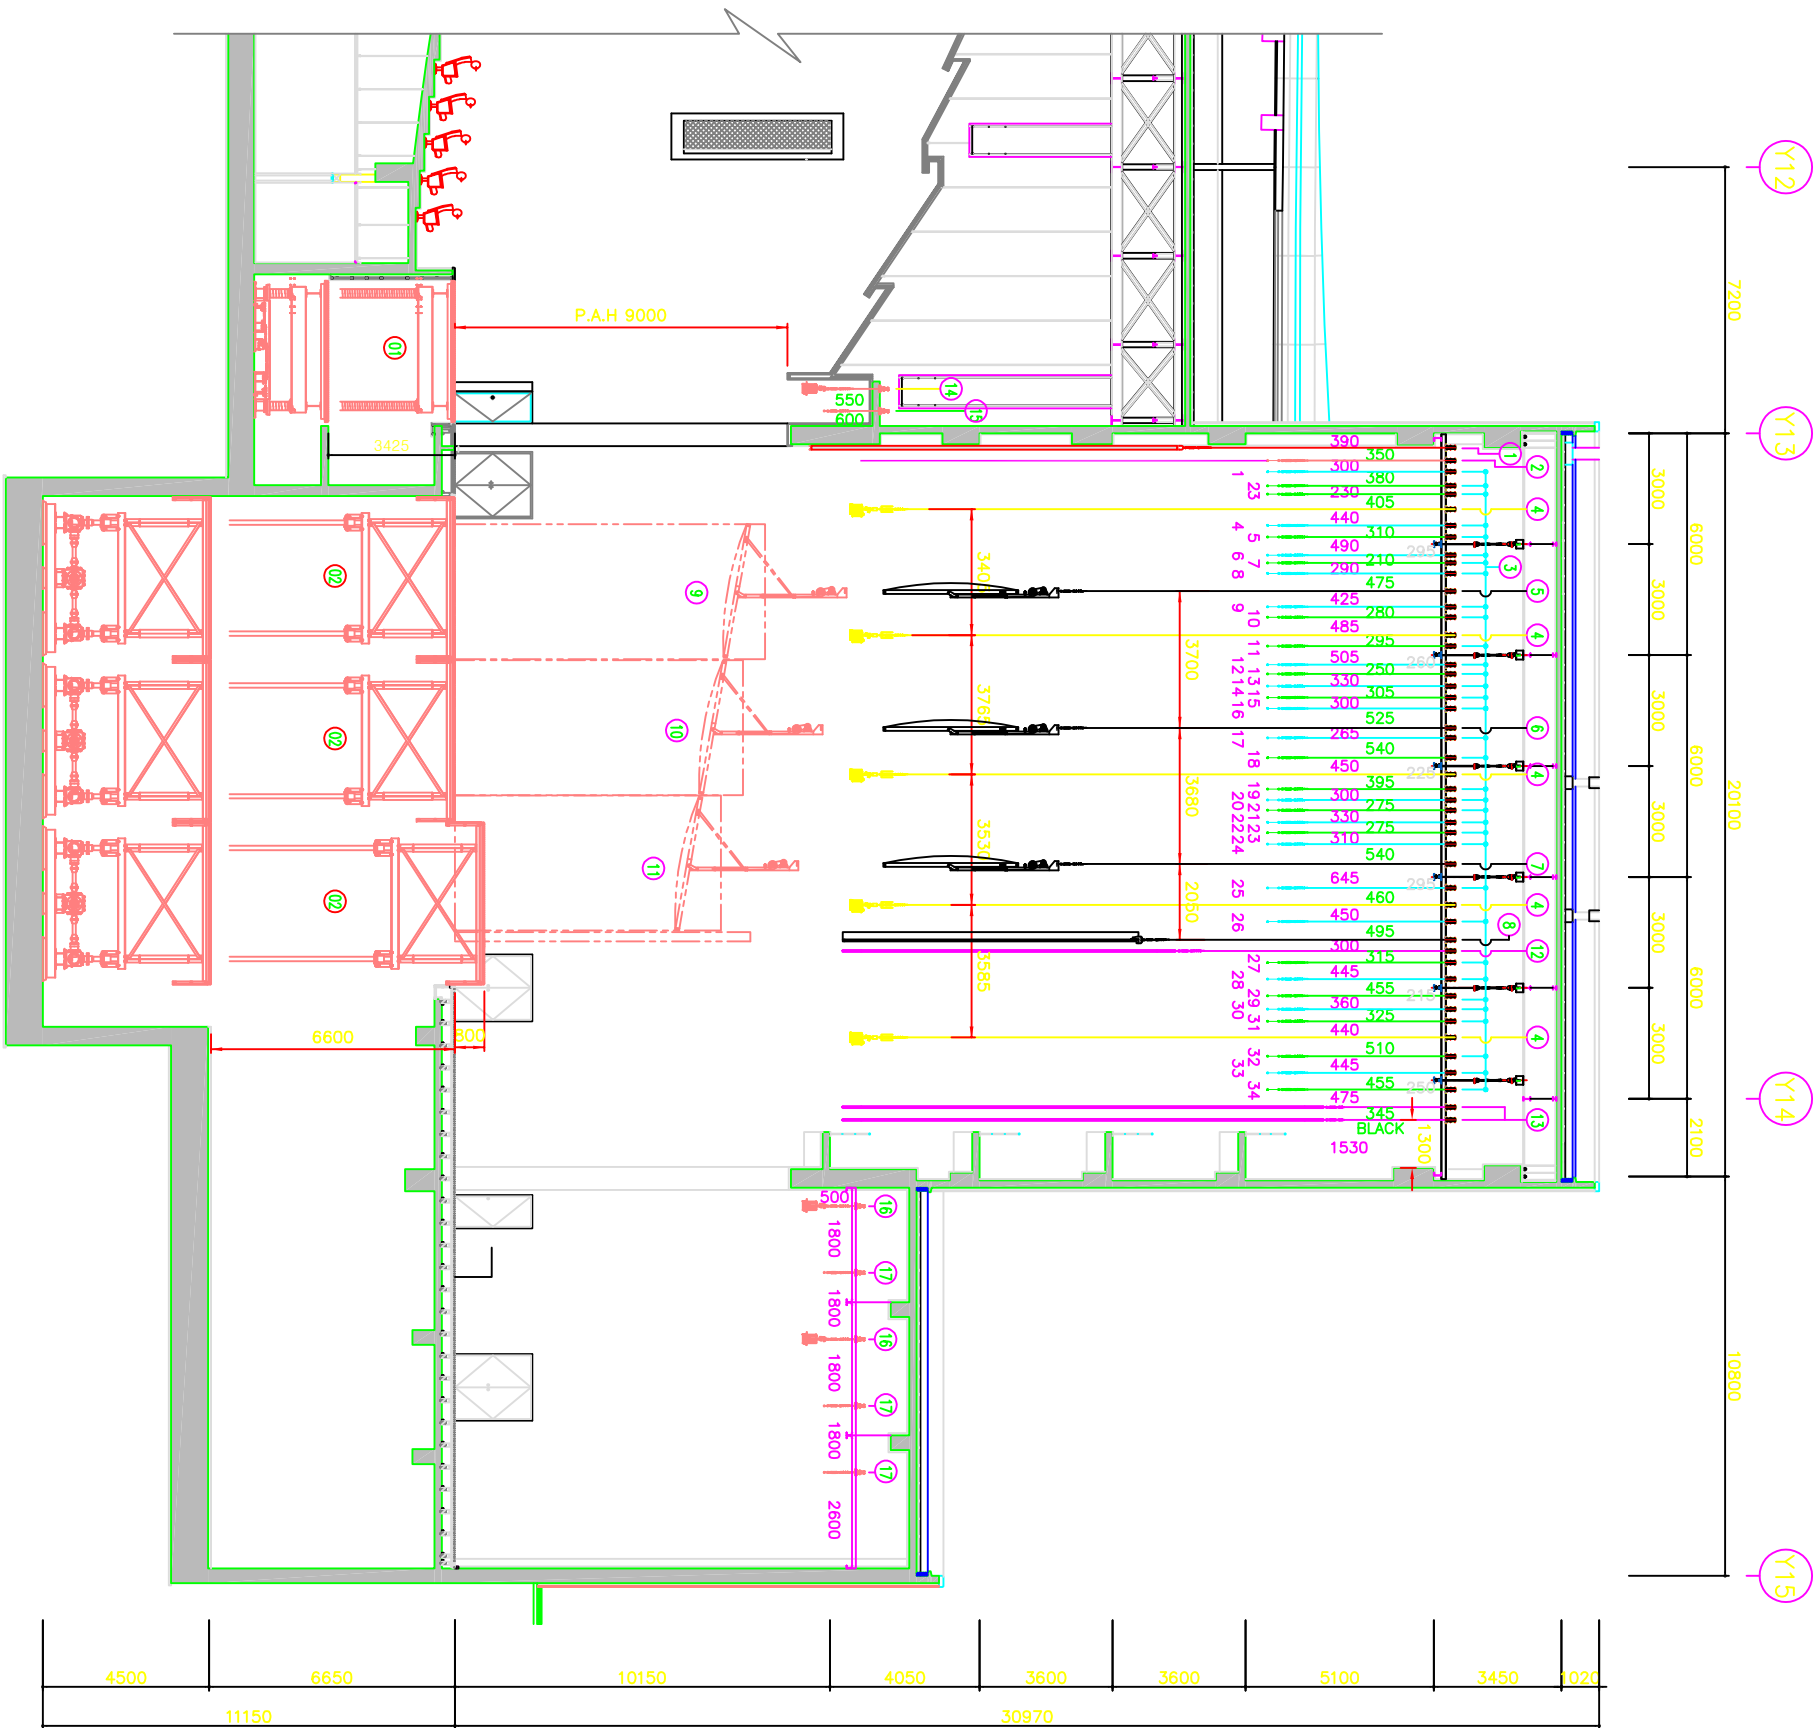


상부 무대기계장치



No.	DESCRIPTION	DIMENSIONS (L x H x W)	POWER (kw x P)	SPEED (m/min)
1	SAFETY CURTAIN	18,000 x 10,000	5.5 x 4	1~18
2	MAIN CURTAIN	20,000 x 11,000	18.5 x 4	1 ~ 60
3	No. 1~27 FLY SET BATTEN	21,000	15 x 4	1 ~ 60
	No. 28~30 FLY SET BATTEN	18,000	15 x 4	1 ~ 60
	No. 31~33 FLY SET BATTEN	16,000	15 x 4	1 ~ 60
	SUB SET BATTEN	16,000	2.2 x 4	14
4	No. 1~4 SUSPENSION LIGHT BATTEN	21,000	4 x 4	9
	No. 5 SUSPENSION LIGHT BATTEN	16,000	4 x 4	9
5	No. 1 UPPER SOUND REFLECTION BOARD	15,200/13,800 x 3,650	UP-DN : 3 x 4 TILTING : 0.4 x 4	6 4
6	No. 2 UPPER SOUND REFLECTION BOARD	13,800/12,400 x 3,650	UP-DN : 3 x 4 TILTING : 0.4 x 4	6 4
7	No. 3 UPPER SOUND REFLECTION BOARD	12,400/11,000 x 3,650	UP-DN : 3 x 4 TILTING : 0.4 x 4	6 4
8	FRONT SOUND REFLECTION BOARD	13,800 x 8,000	3 x 4	6
9	No. 1~2 SIDE SOUND REFLECTION BOARD	3,650 x 8,400	2.2 x 4	6
10	No. 3~4 SIDE SOUND REFLECTION BOARD	3,650 x 7,800	2.2 x 4	6
11	No. 5~6 SIDE SOUND REFLECTION BOARD	3,650 x 7,200	2.2 x 4	6
12	PROJECT & REAR SCREEN	18,000 x 10,000	15 x 4	1 ~ 60
13	HORIZONTAL CURTAIN (WHITE)	22,500 x 12,000	3 x 4	15
14	HORIZONTAL CURTAIN (BLACK)	22,500 x 12,000	3 x 4	15
15	CEILING LIGHT BATTEN	17,000	4 x 4	9
16	PLACARD BATTEN	17,000	4 x 4	9
17	No. 1~2 BACK STAGE LIGHT BATTEN	17,000	3.75 x 4	9
18	No. 1~3 BACK STAGE SET BATTEN	17,000	3.75 x 4	9

하부 무대기계장치

No.	DESCRIPTION	DIMENSIONS (L x H x W)	POWER (kw x P)	SPEED (m/min)
01	ORCHESTRA LIFT	18,000 x 3,828	15 x 4 : 2UNIT	3
02	No. 1~3 STAGE LIFT	14,390 x 4,390	75 x 6	1 ~ 9
03	No. 1~3 SIDE SUB SINKING STAGE	3,490 x 4,390	5.5 x 4	1
04	No. 1~3 WAGON SINKING STAGE	14,390 x 4,390	2.2 x 4	1
05	No. 1~3 WAGON STAGE	14,390 x 4,390	2.2 x 4	1

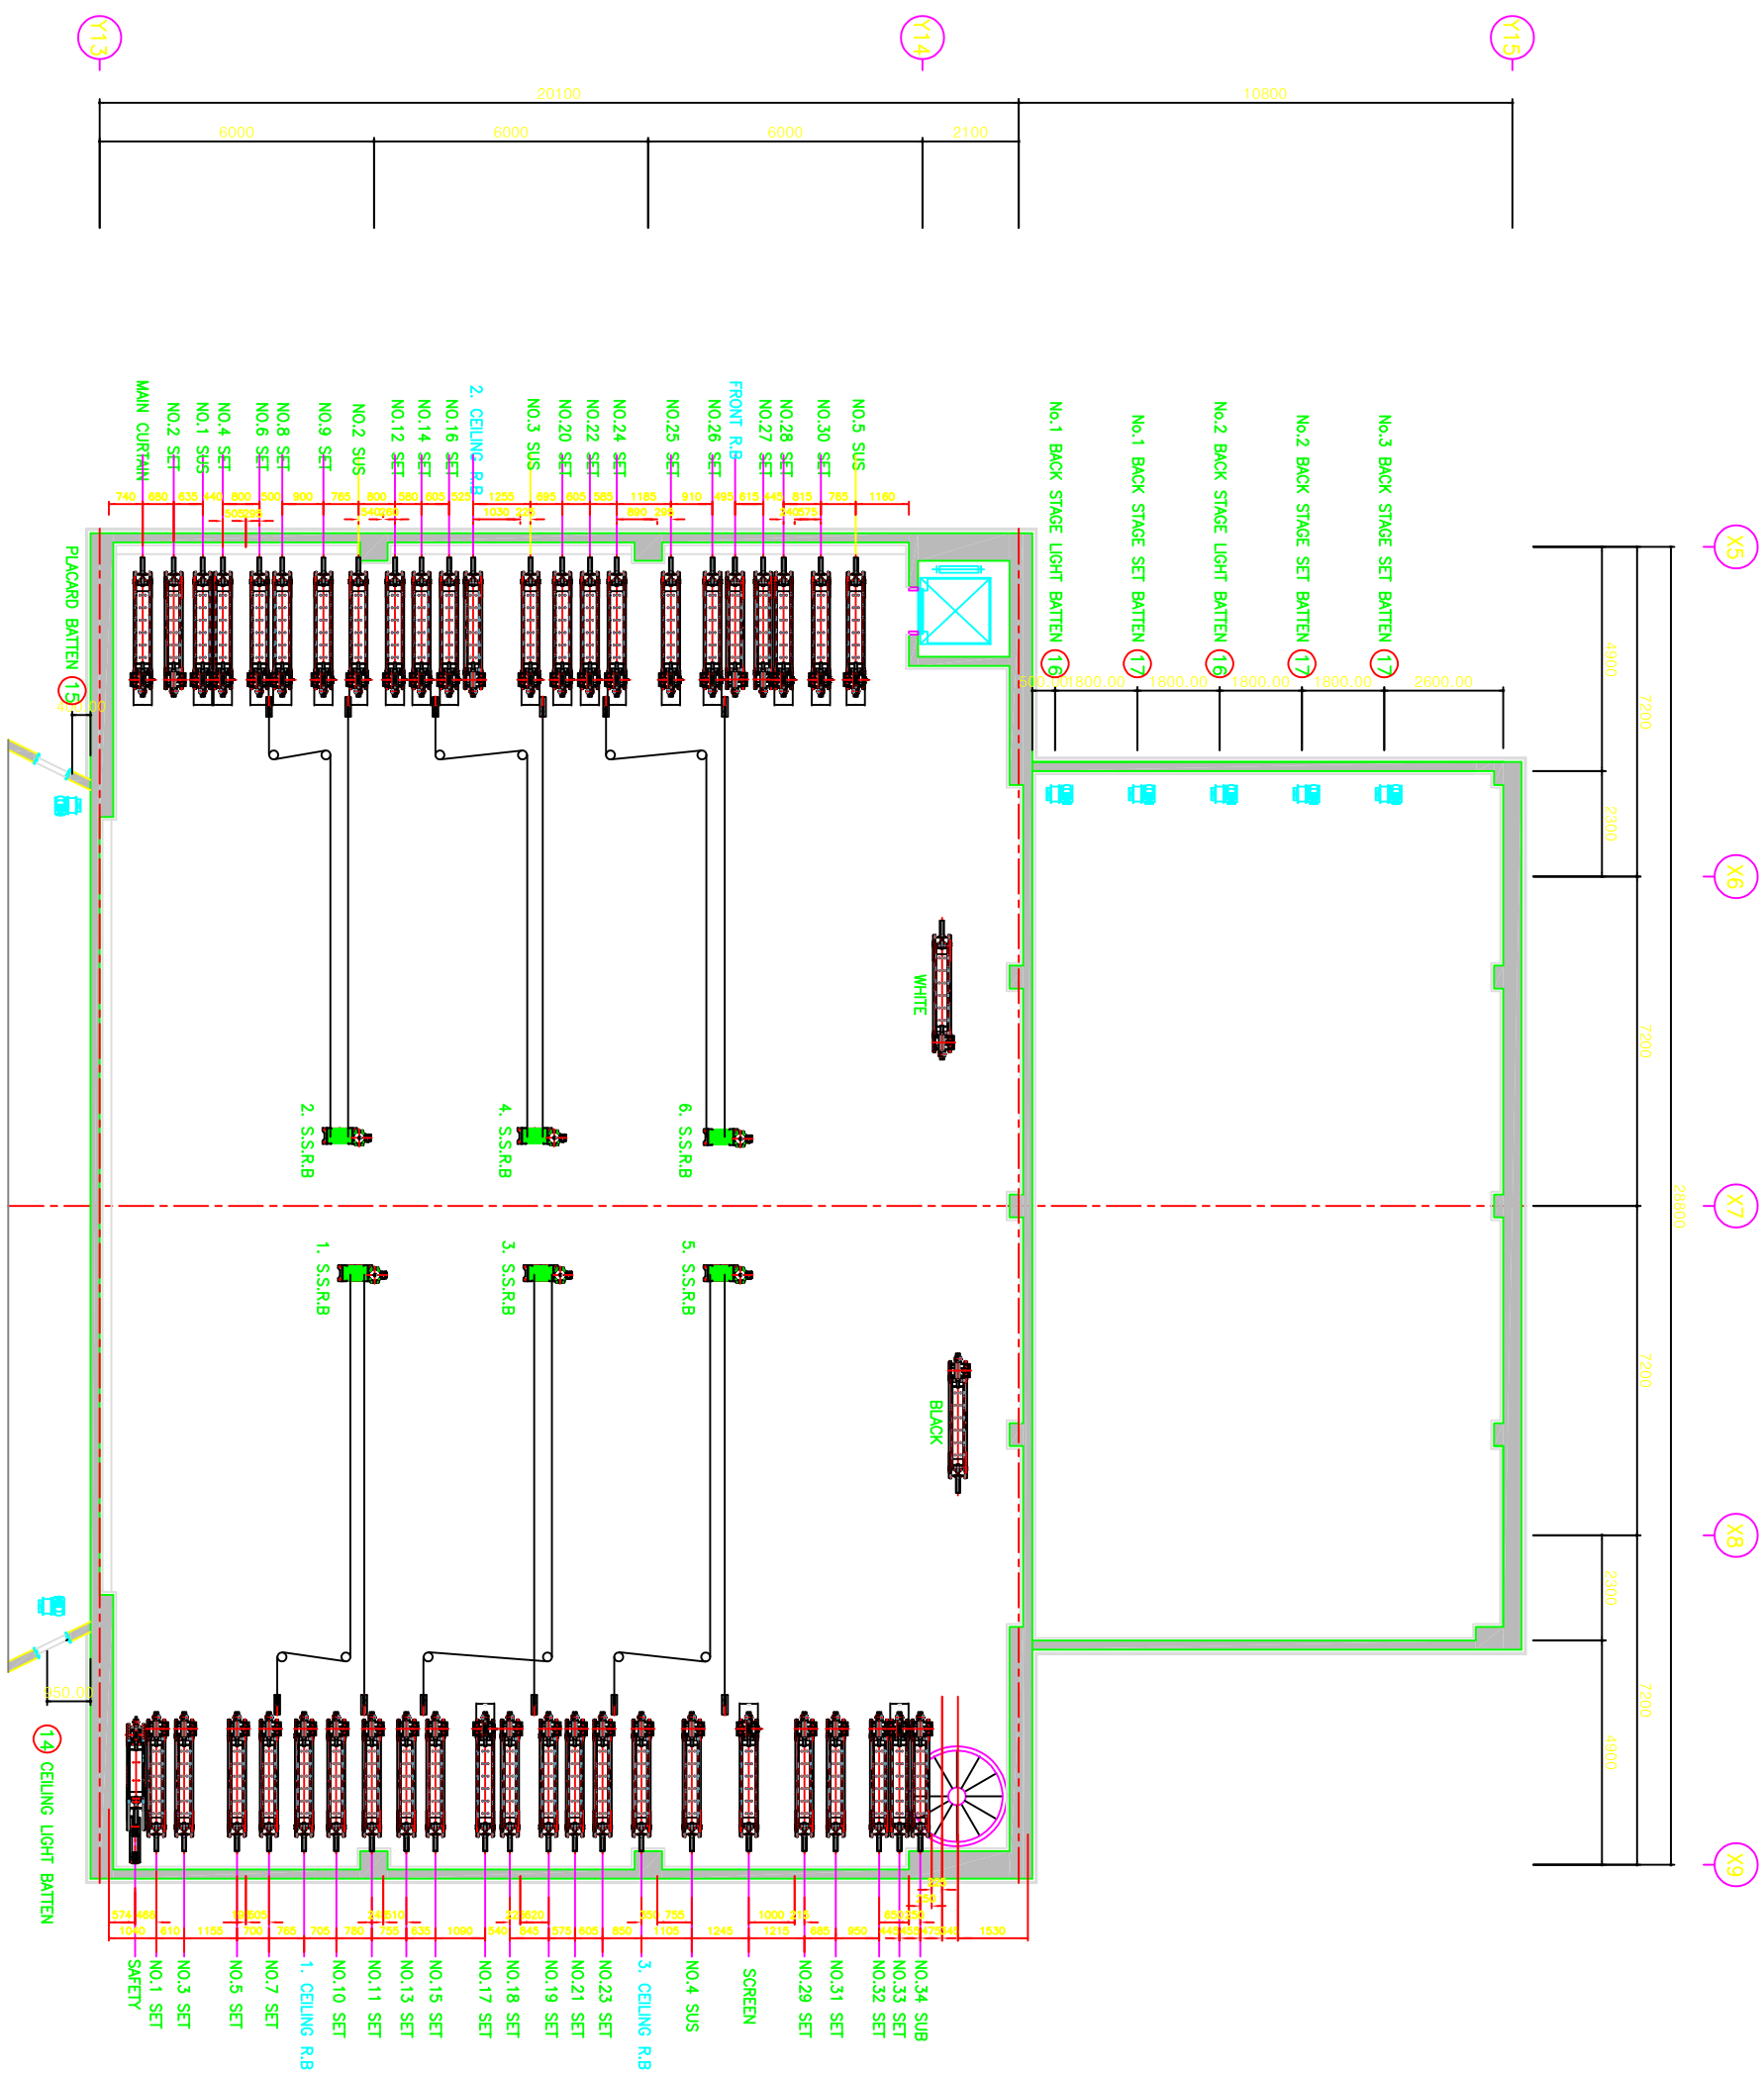

NOTE

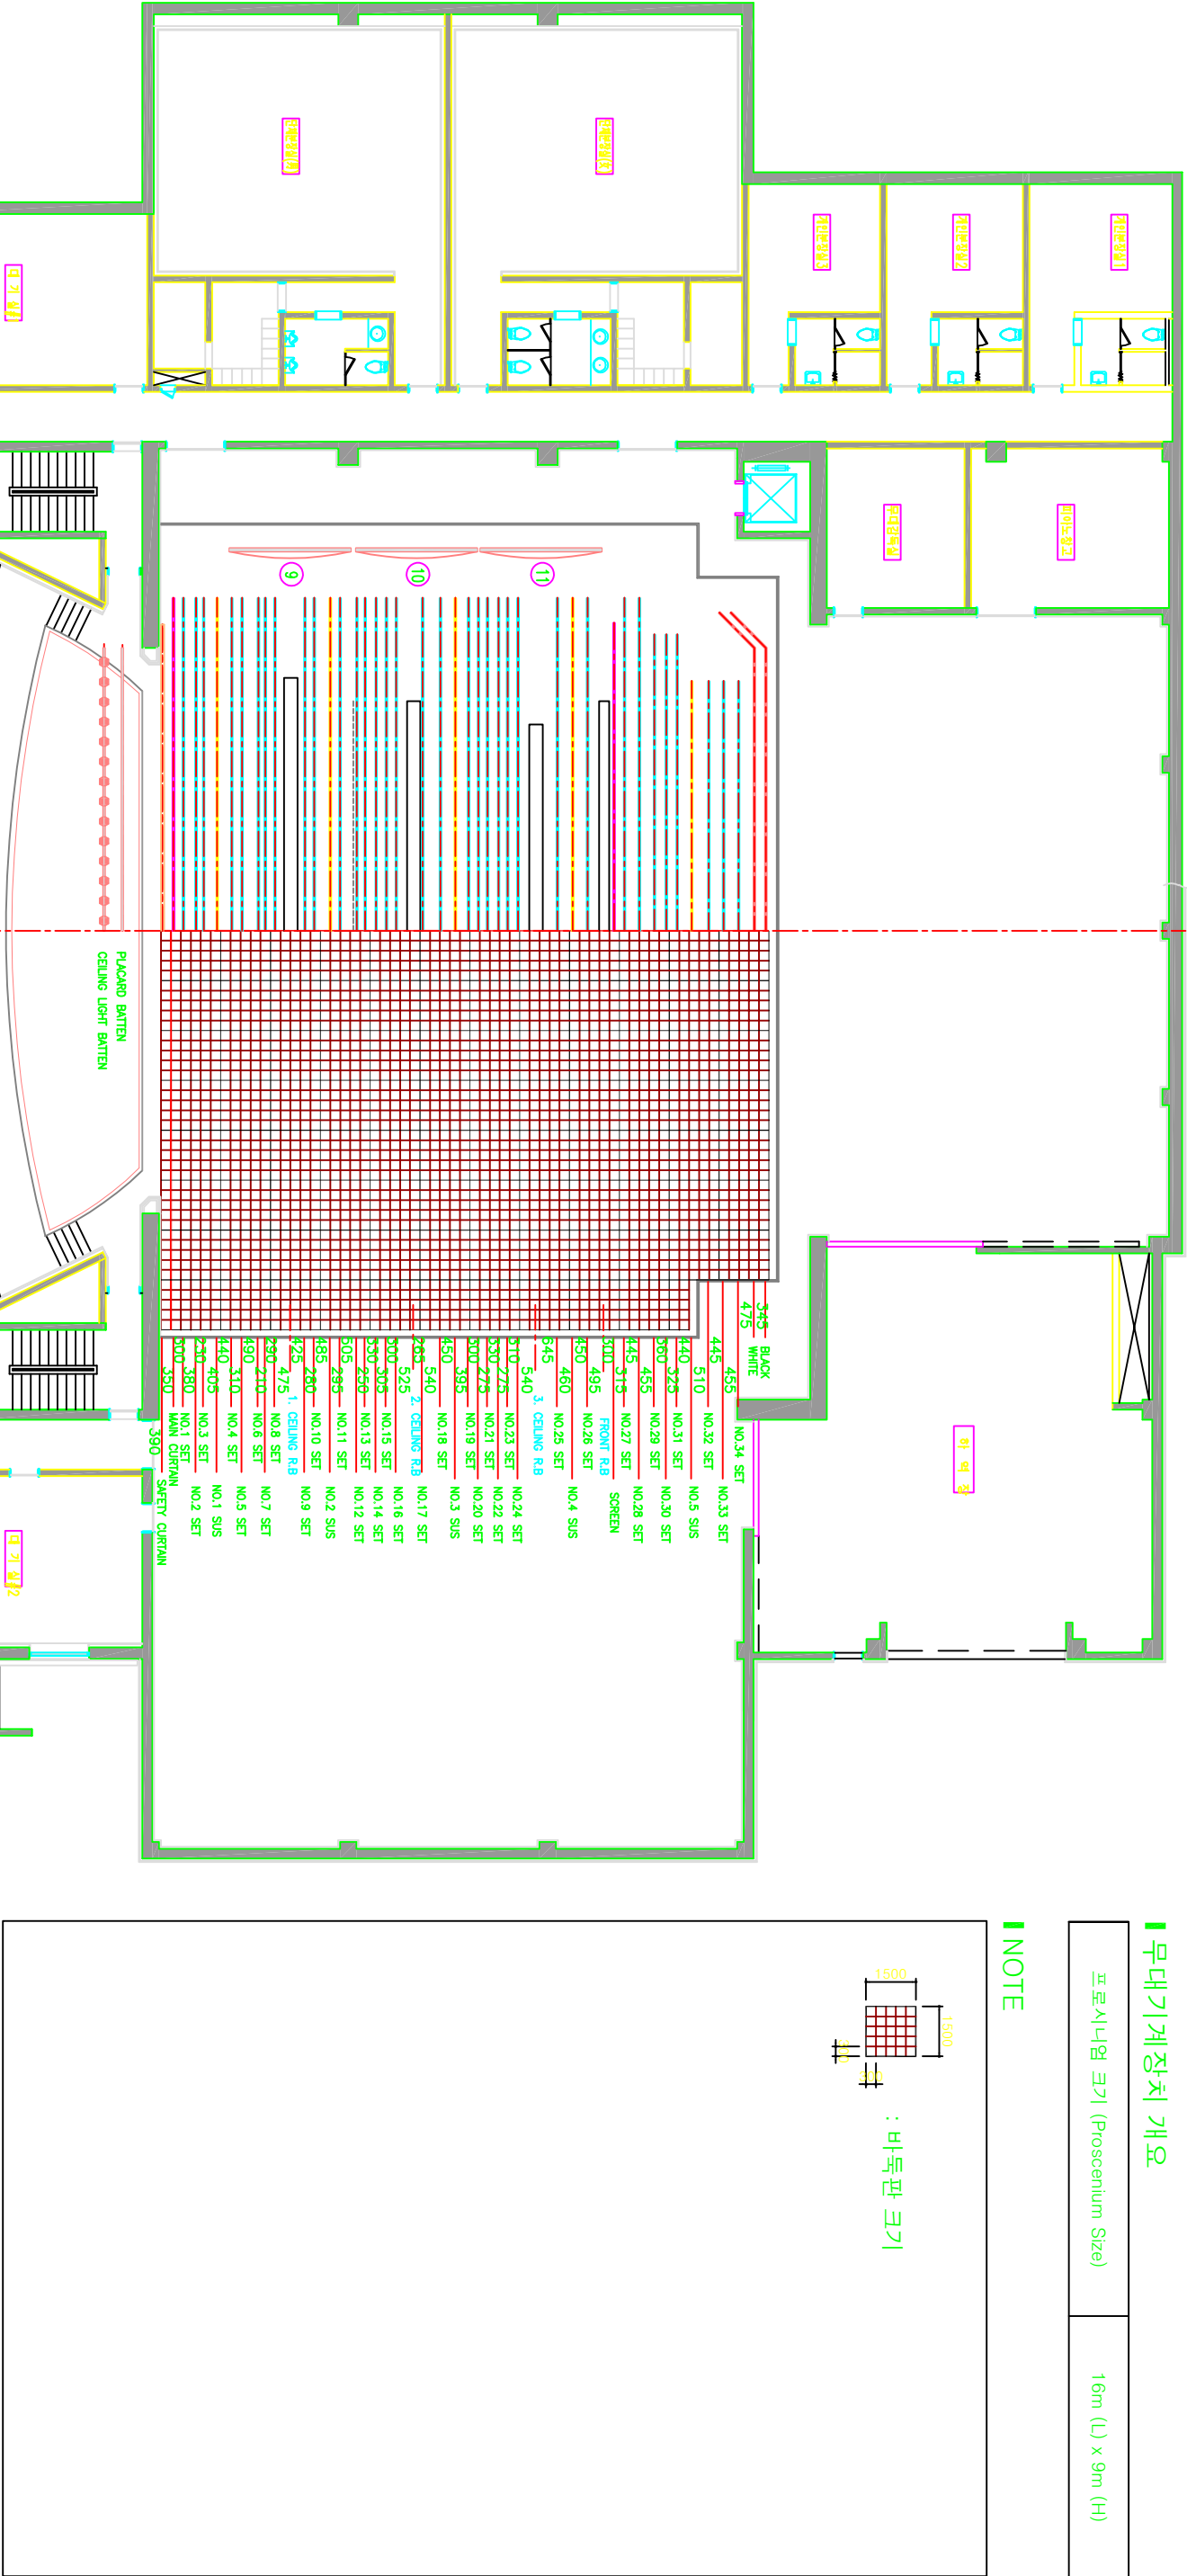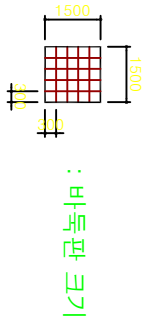

FLY SET BATTEN 일람표

No.	DESCRIPTION	DIMENSIONS	SPEED (m/min)	TYPE	SET NAME	No.	DESCRIPTION	DIMENSIONS	SPEED (m/min)	TYPE	SET NAME	No.	DESCRIPTION	DIMENSIONS	SPEED (m/min)	TYPE	SET NAME
No.1	FLY SET BATTEN	21,000 L	1 ~ 60	WINCH		No.13	FLY SET BATTEN	21,000 L	1 ~ 60	WINCH		No.25	FLY SET BATTEN	21,000 L	1 ~ 60	WINCH	
No.2	FLY SET BATTEN	21,000 L	1 ~ 60	WINCH		No.14	FLY SET BATTEN	21,000 L	1 ~ 60	WINCH		No.26	FLY SET BATTEN	21,000 L	1 ~ 60	WINCH	
No.3	FLY SET BATTEN	21,000 L	1 ~ 60	WINCH		No.15	FLY SET BATTEN	21,000 L	1 ~ 60	WINCH		No.27	FLY SET BATTEN	21,000 L	1 ~ 60	WINCH	
No.4	FLY SET BATTEN	21,000 L	1 ~ 60	WINCH		No.16	FLY SET BATTEN	21,000 L	1 ~ 60	WINCH		No.28	FLY SET BATTEN	18,000 L	1 ~ 60	WINCH	
No.5	FLY SET BATTEN	21,000 L	1 ~ 60	WINCH		No.17	FLY SET BATTEN	21,000 L	1 ~ 60	WINCH		No.29	FLY SET BATTEN	18,000 L	1 ~ 60	WINCH	
No.6	FLY SET BATTEN	21,000 L	1 ~ 60	WINCH		No.18	FLY SET BATTEN	21,000 L	1 ~ 60	WINCH		No.30	FLY SET BATTEN	18,000 L	1 ~ 60	WINCH	
No.7	FLY SET BATTEN	21,000 L	1 ~ 60	WINCH		No.19	FLY SET BATTEN	21,000 L	1 ~ 60	WINCH		No.31	FLY SET BATTEN	16,000 L	1 ~ 60	WINCH	
No.8	FLY SET BATTEN	21,000 L	1 ~ 60	WINCH		No.20	FLY SET BATTEN	21,000 L	1 ~ 60	WINCH		No.32	FLY SET BATTEN	16,000 L	1 ~ 60	WINCH	
No.9	FLY SET BATTEN	21,000 L	1 ~ 60	WINCH		No.21	FLY SET BATTEN	21,000 L	1 ~ 60	WINCH		No.33	FLY SET BATTEN	16,000 L	1 ~ 60	WINCH	
No.10	FLY SET BATTEN	21,000 L	1 ~ 60	WINCH		No.22	FLY SET BATTEN	21,000 L	1 ~ 60	WINCH							
No.11	FLY SET BATTEN	21,000 L	1 ~ 60	WINCH		No.23	FLY SET BATTEN	21,000 L	1 ~ 60	WINCH							
No.12	FLY SET BATTEN	21,000 L	1 ~ 60	WINCH		No.24	FLY SET BATTEN	21,000 L	1 ~ 60	WINCH							

무대기계장치 개요

프로시니엄 크기 (Proscenium Size)	16m (L) x 9m (H)
----------------------------	------------------

하부 무대기계장치

DESCRIPTION	Q'ty	SPEED (m/min)	이동거리	REMARK
오케스트라 리프트 (Orchestra Lift)	1 Set	3	3.425 m	
주무대 리프트 (Main Stage Lift)	3 Set	1 ~ 9.2	UP : 0.8 m DOWN : 6.6 m	
소형 보조 침하무대 (Side Sub Sinking Stage)	3 Set	1	0.36 m	
이동무대 (Wagon Stage)	3 Set	1~18	17.9 m	
침하무대 (Wagon Sinking Stage)	3 Set	1	0.36 m	

NOTE

1500

1500

바둑판 크기


1500

1500



바둑판 크기

FLY SET BATTEN 일람표

No.	DESCRIPTION	DIMENSIONS	SPEED (m/min)	TYPE	SET NAME	No.	DESCRIPTION	DIMENSIONS	SPEED (m/min)	TYPE	SET NAME	No.	DESCRIPTION	DIMENSIONS	SPEED (m/min)	TYPE	SET NAME
No.1	FLY SET BATTEN	21,000 L	1 ~ 60	WINCH		No.13	FLY SET BATTEN	21,000 L	1 ~ 60	WINCH		No.25	FLY SET BATTEN	21,000 L	1 ~ 60	WINCH	
No.2	FLY SET BATTEN	21,000 L	1 ~ 60	WINCH		No.14	FLY SET BATTEN	21,000 L	1 ~ 60	WINCH		No.26	FLY SET BATTEN	21,000 L	1 ~ 60	WINCH	
No.3	FLY SET BATTEN	21,000 L	1 ~ 60	WINCH		No.15	FLY SET BATTEN	21,000 L	1 ~ 60	WINCH		No.27	FLY SET BATTEN	21,000 L	1 ~ 60	WINCH	
No.4	FLY SET BATTEN	21,000 L	1 ~ 60	WINCH		No.16	FLY SET BATTEN	21,000 L	1 ~ 60	WINCH		No.28	FLY SET BATTEN	18,000 L	1 ~ 60	WINCH	
No.5	FLY SET BATTEN	21,000 L	1 ~ 60	WINCH		No.17	FLY SET BATTEN	21,000 L	1 ~ 60	WINCH		No.29	FLY SET BATTEN	18,000L	1 ~ 60	WINCH	
No.6	FLY SET BATTEN	21,000 L	1 ~ 60	WINCH		No.18	FLY SET BATTEN	21,000 L	1 ~ 60	WINCH		No.30	FLY SET BATTEN	18,000L	1 ~ 60	WINCH	
No.7	FLY SET BATTEN	21,000 L	1 ~ 60	WINCH		No.19	FLY SET BATTEN	21,000 L	1 ~ 60	WINCH		No.31	FLY SET BATTEN	16,000L	1 ~ 60	WINCH	
No.8	FLY SET BATTEN	21,000 L	1 ~ 60	WINCH		No.20	FLY SET BATTEN	21,000 L	1 ~ 60	WINCH		No.32	FLY SET BATTEN	16,000L	1 ~ 60	WINCH	
No.9	FLY SET BATTEN	21,000 L	1 ~ 60	WINCH		No.21	FLY SET BATTEN	21,000 L	1 ~ 60	WINCH		No.33	FLY SET BATTEN	16,000L	1 ~ 60	WINCH	
No.10	FLY SET BATTEN	21,000 L	1 ~ 60	WINCH		No.22	FLY SET BATTEN	21,000 L	1 ~ 60	WINCH		SUB SET BATTEN		16,000L	14	WINCH	
No.11	FLY SET BATTEN	21,000 L	1 ~ 60	WINCH		No.23	FLY SET BATTEN	21,000 L	1 ~ 60	WINCH							
No.12	FLY SET BATTEN	21,000 L	1 ~ 60	WINCH		No.24	FLY SET BATTEN	21,000 L	1 ~ 60	WINCH							

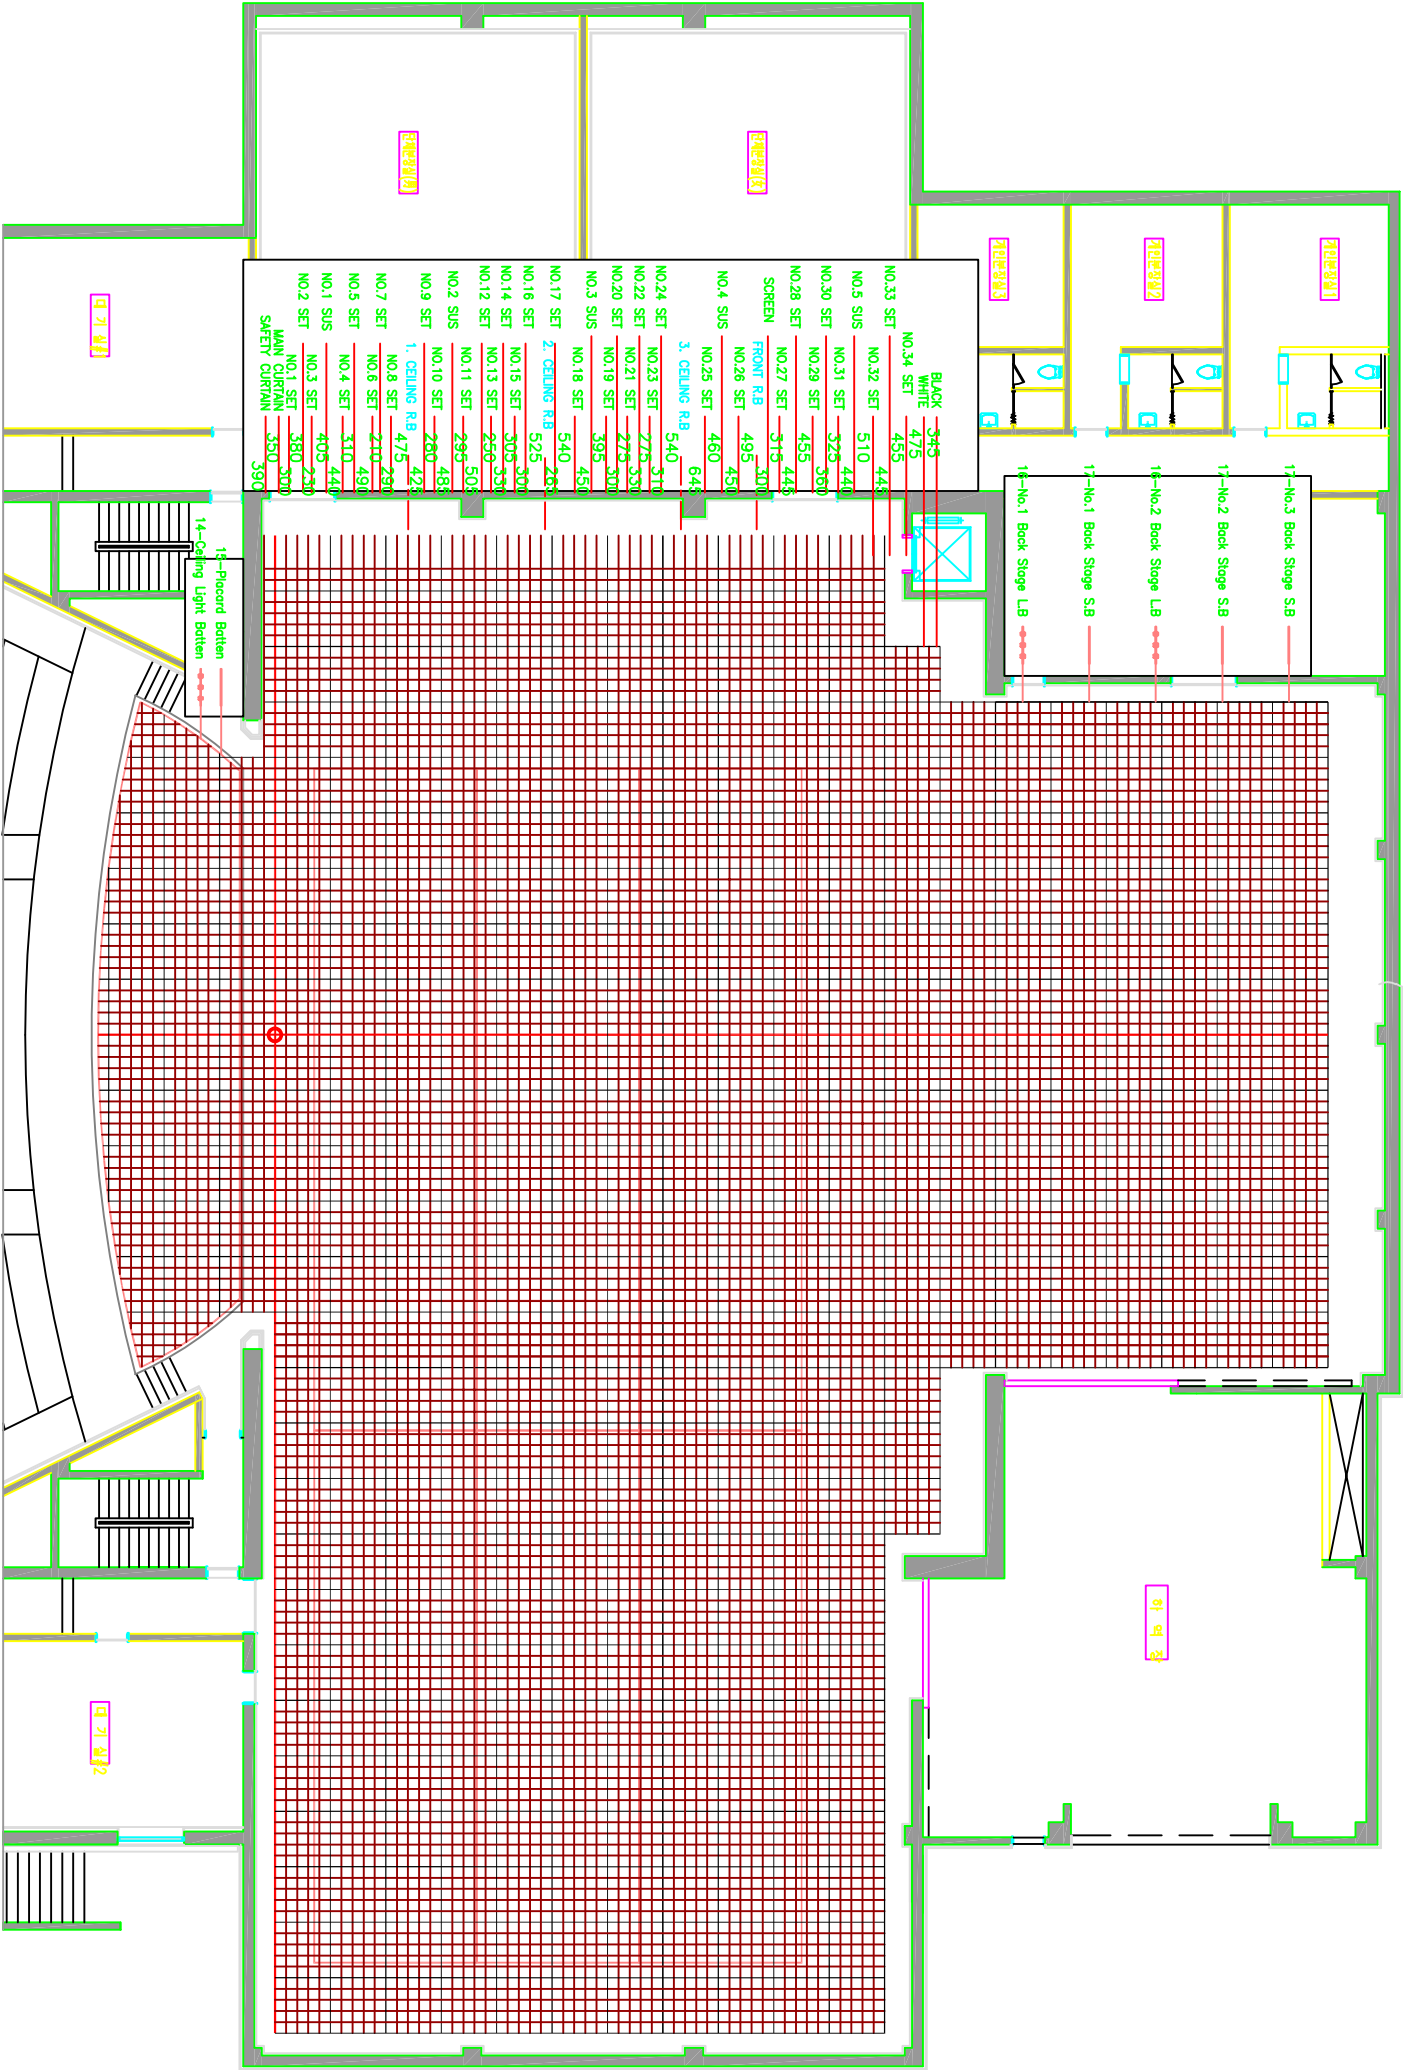

대극장 무대기계장치 배치도

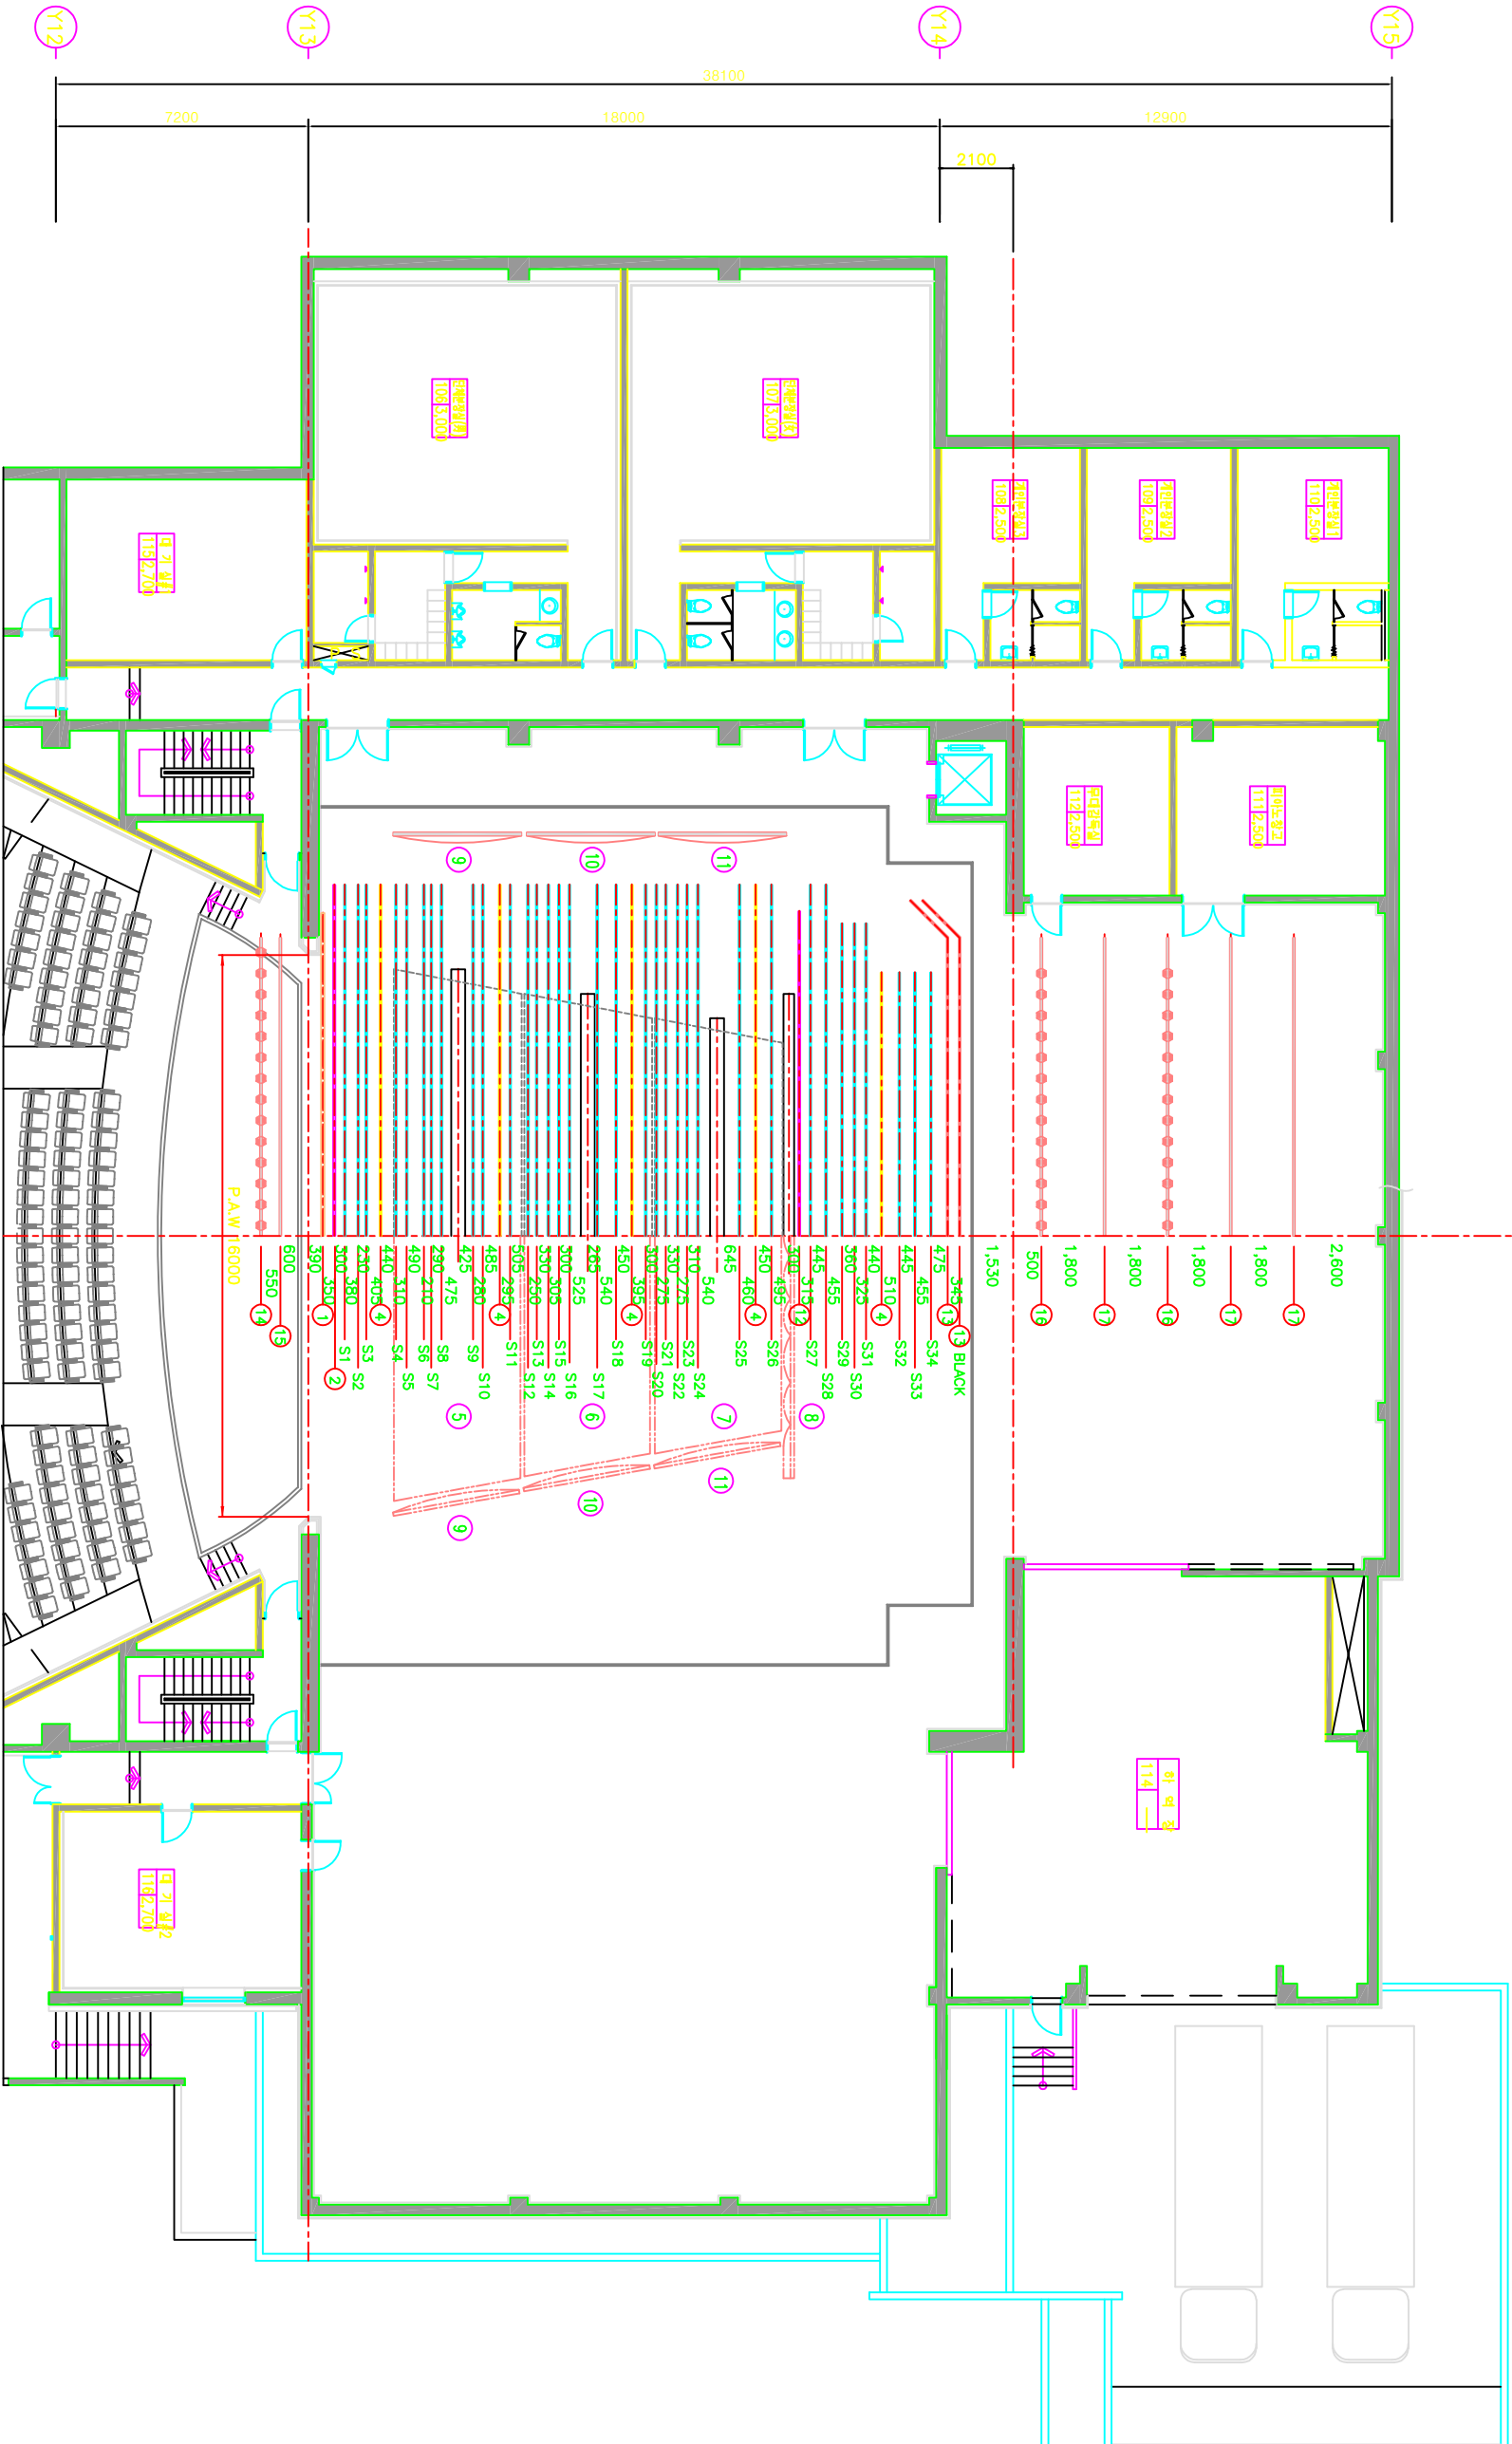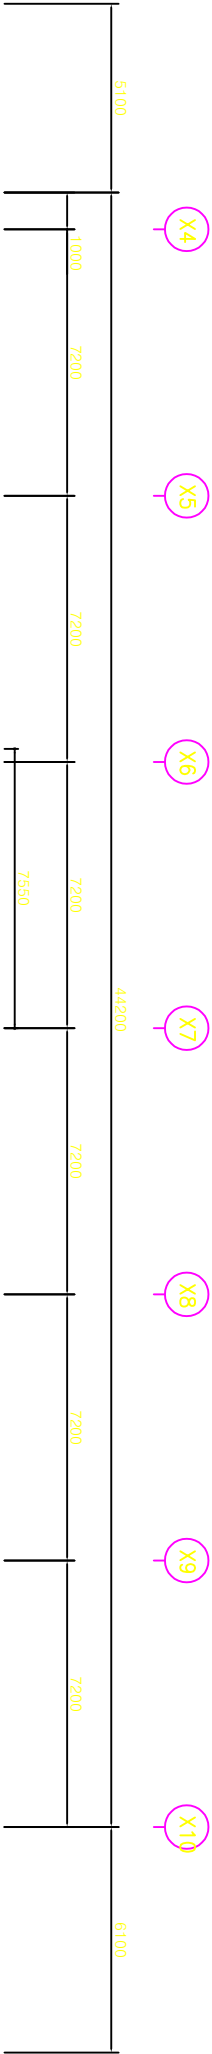

도면명

대극장 무대기계장치 상부 평면배치도

축척



1/100 (A1)

도면번호

SS-002

일련번호

002

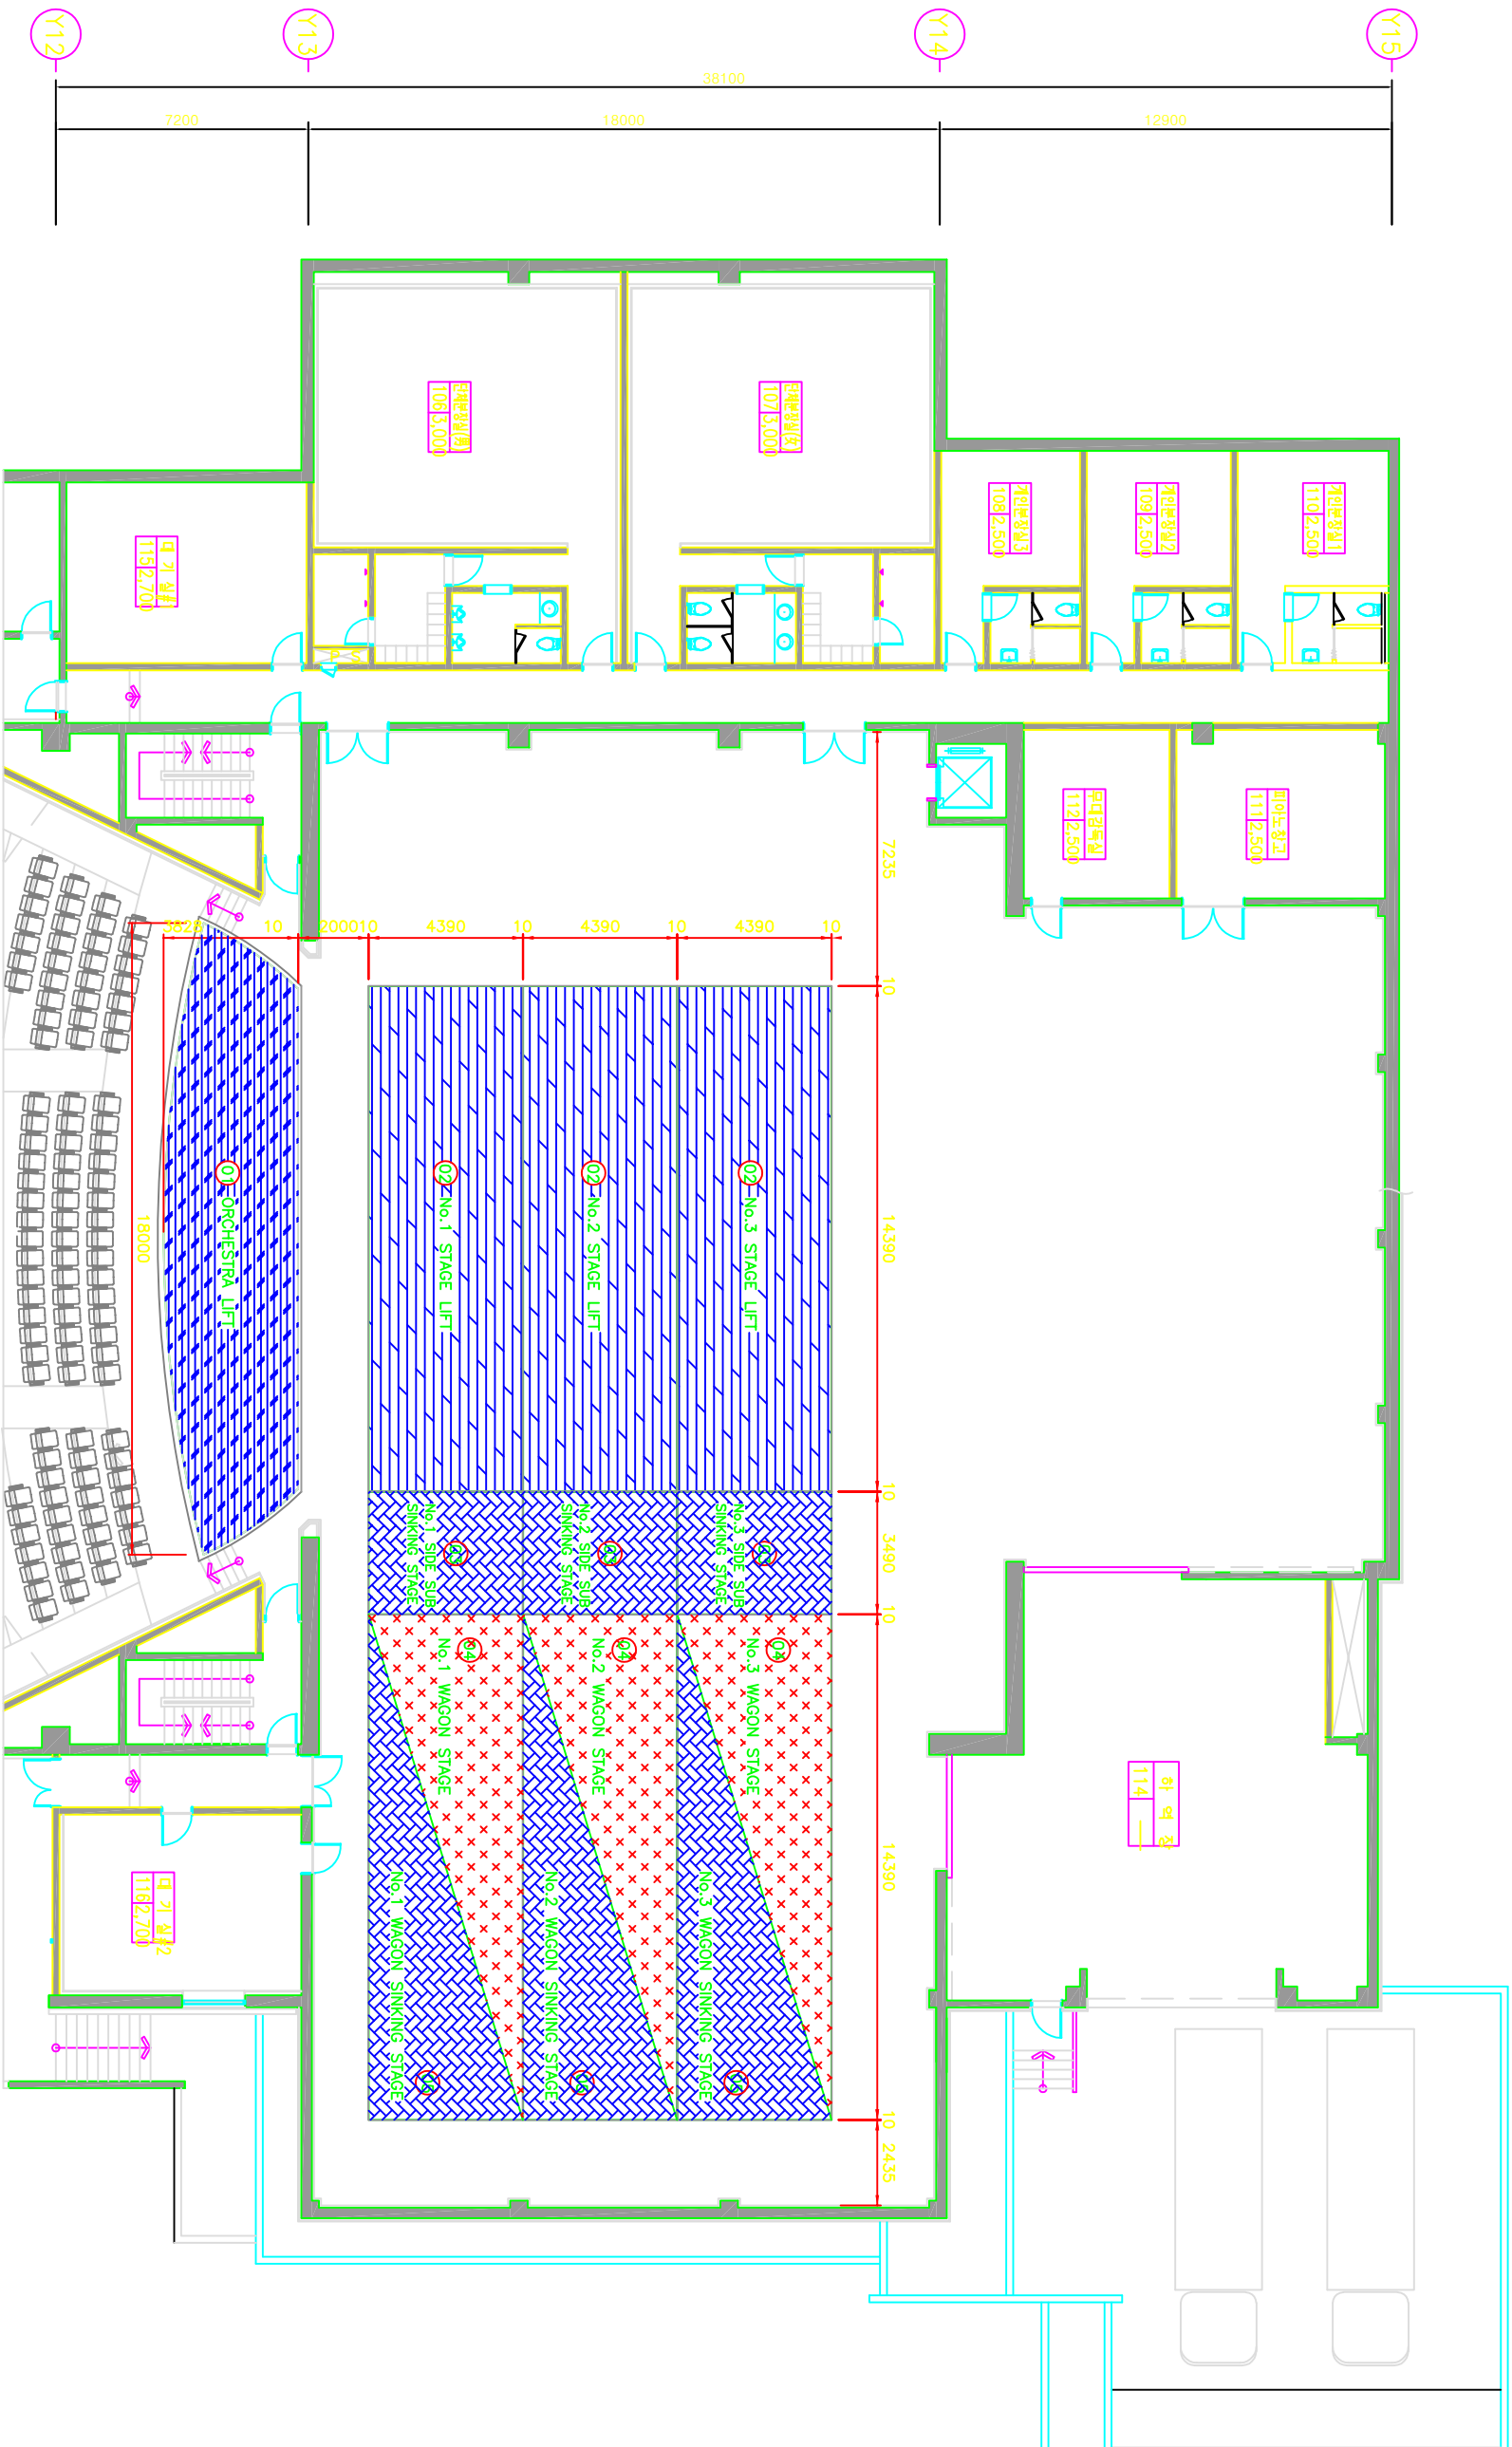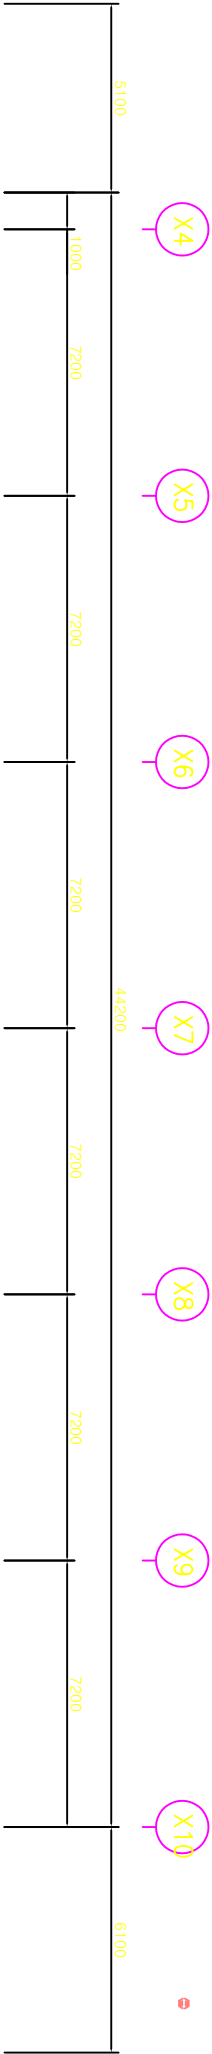

도면명

대극장 무대기계장치 하부 평면배치도

축척

1 / 100 (A1)

도면번호

SS-003

일련번호

003